


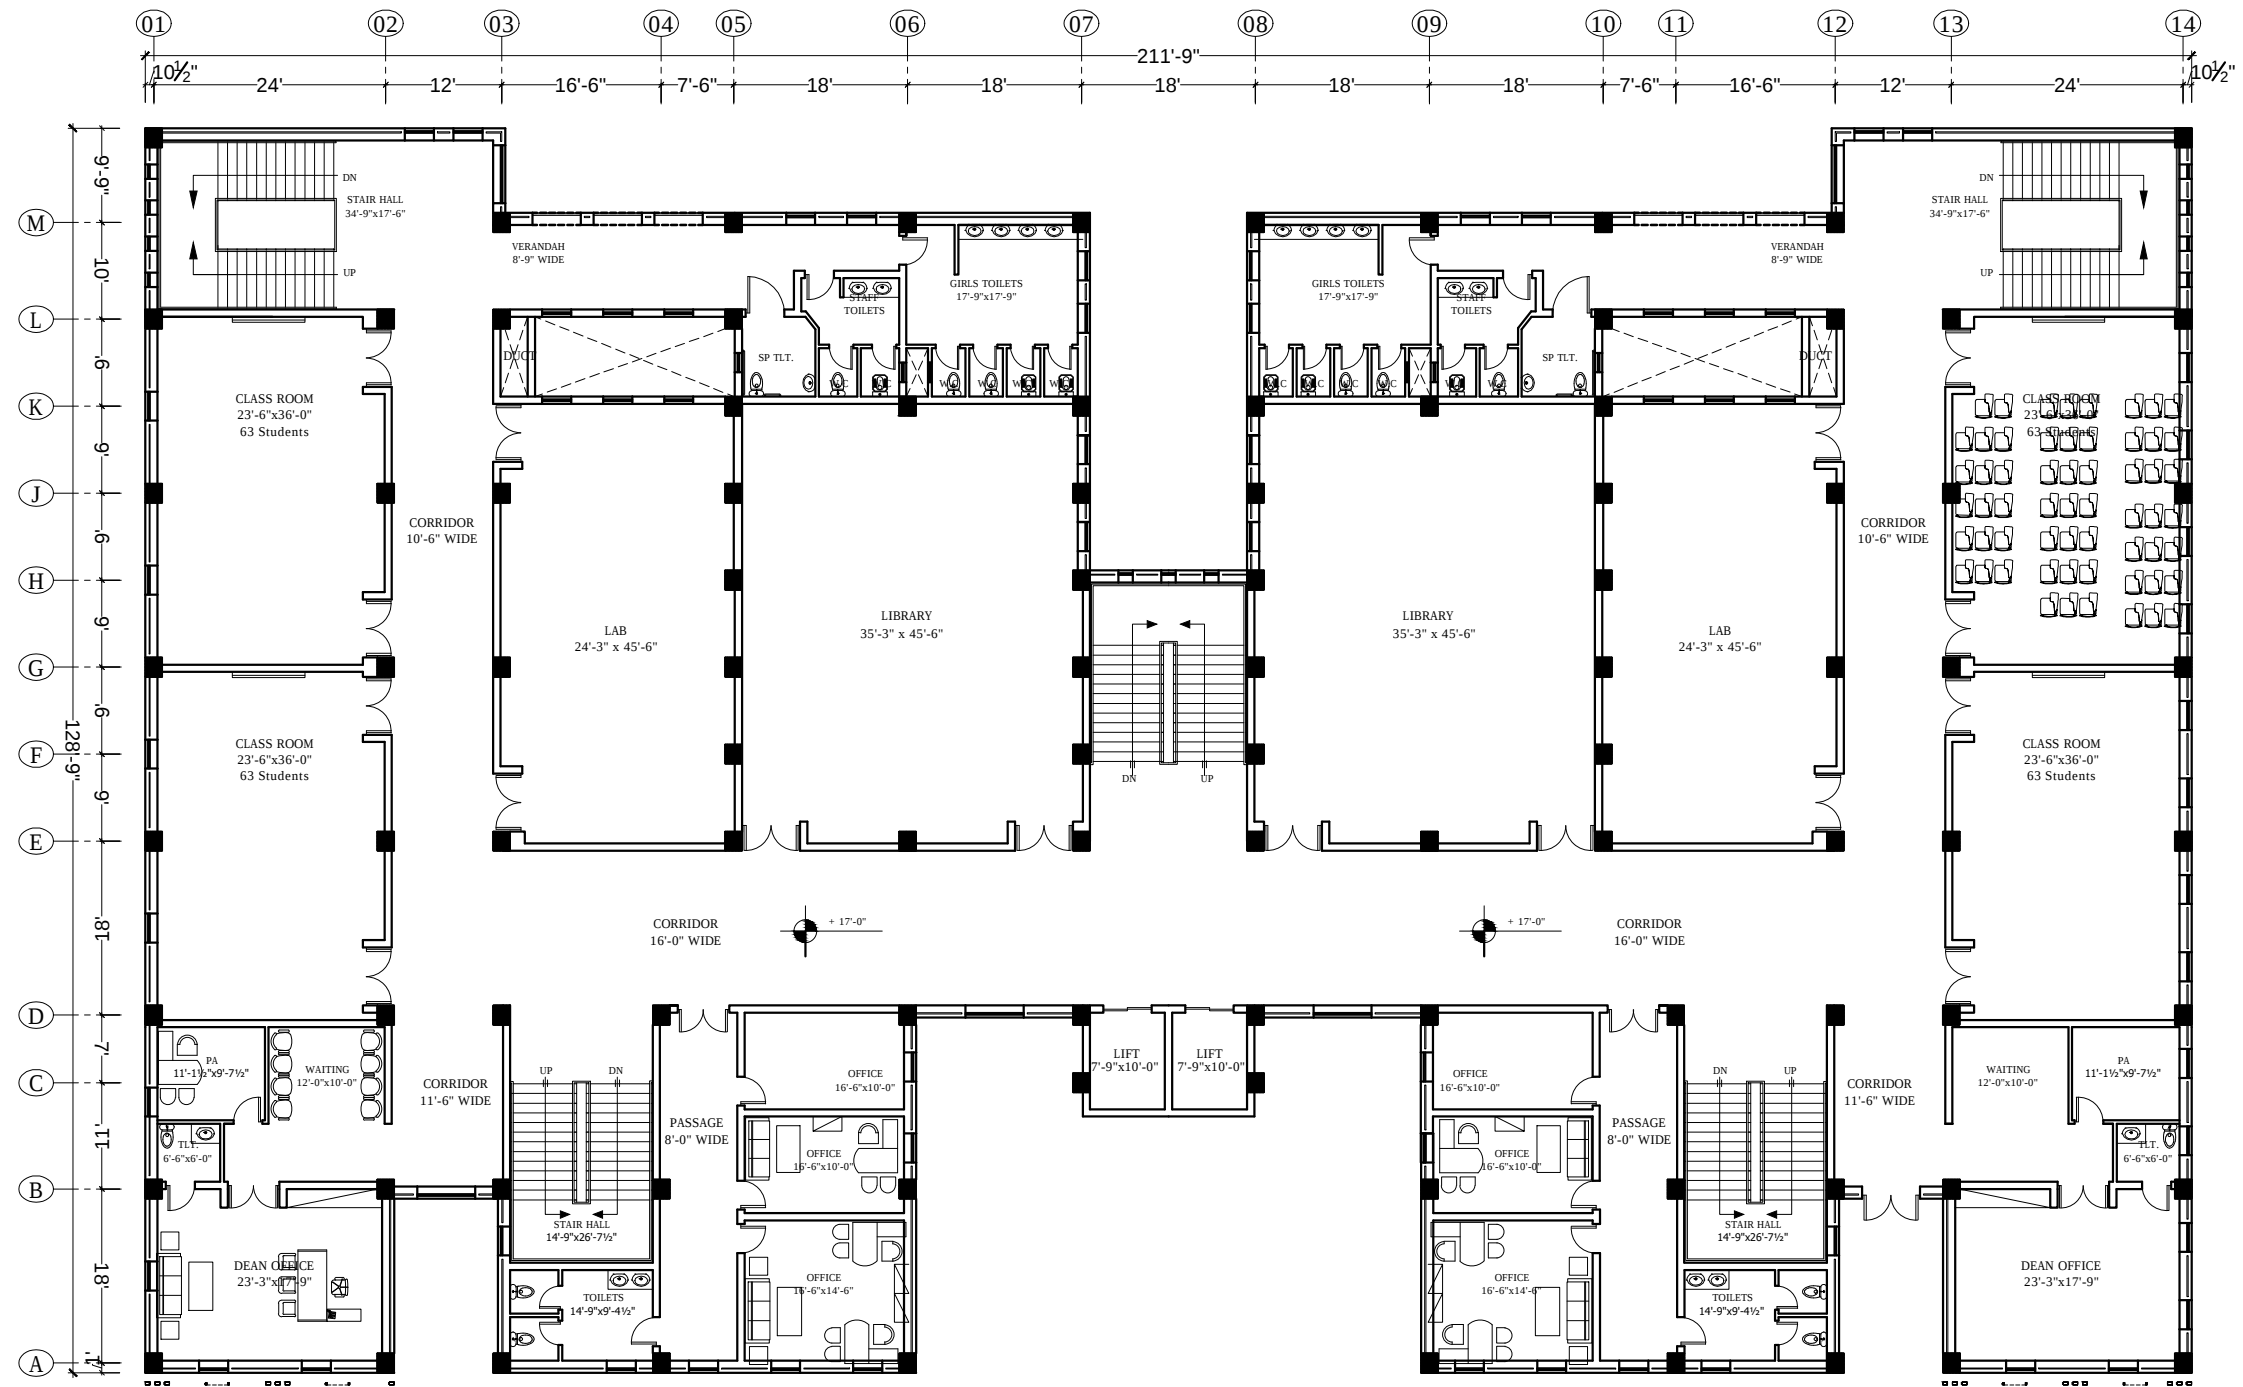

FIRST FLOOR PLAN

CLIENT. GOVERNMENT COLLEGE UNIVERSITY FAISALABAD	PROJECT. ESTABLISHMENT OF CHINIOT CAMPUS GOVERNMENT COLLEGE UNIVERSITY FAISALABAD	NORTH 	DWG. TITLE ACADEMIC BLOCK FIRST FLOOR FURNITURE PLAN	DWG. NO A - 03	CONSULTANTS  DEVELOPMENT CONSULTANCY SERVICES (Pvt.) Ltd. Office 27, 2nd Floor, Executive complex, G-8 Markaz, Islamabad Phone: 051-8736305
---	---	---	---	------------------------------	--