

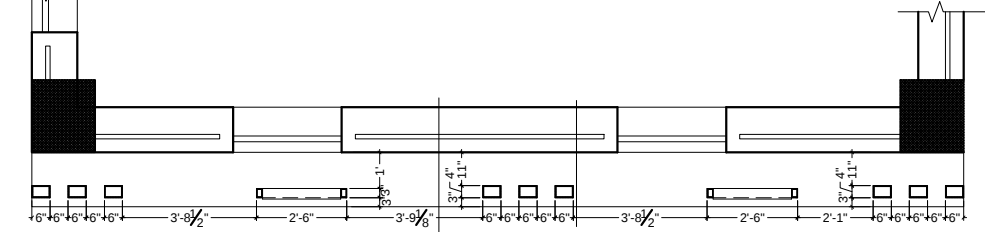
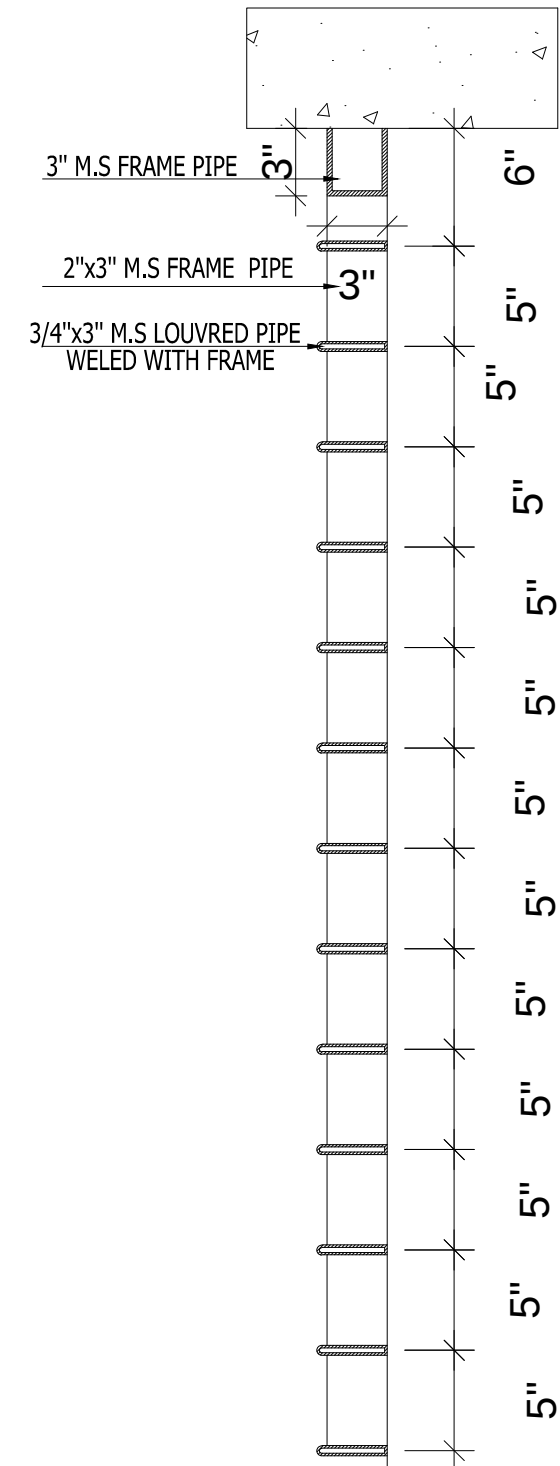


SECOND FLOOR PLAN

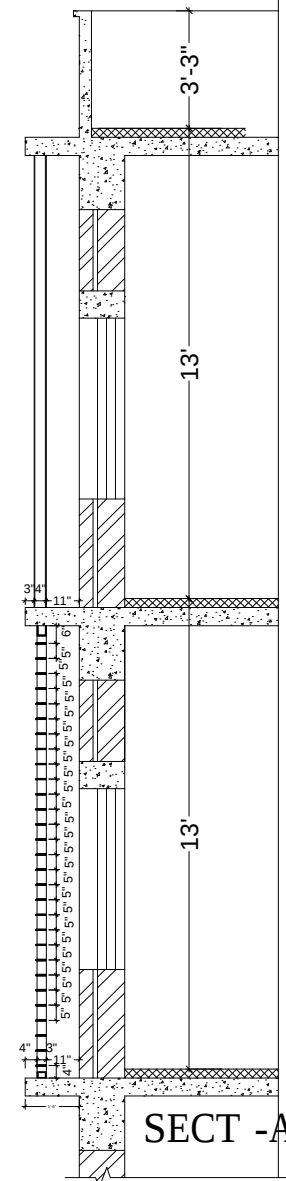

FIRST FLOOR PLAN

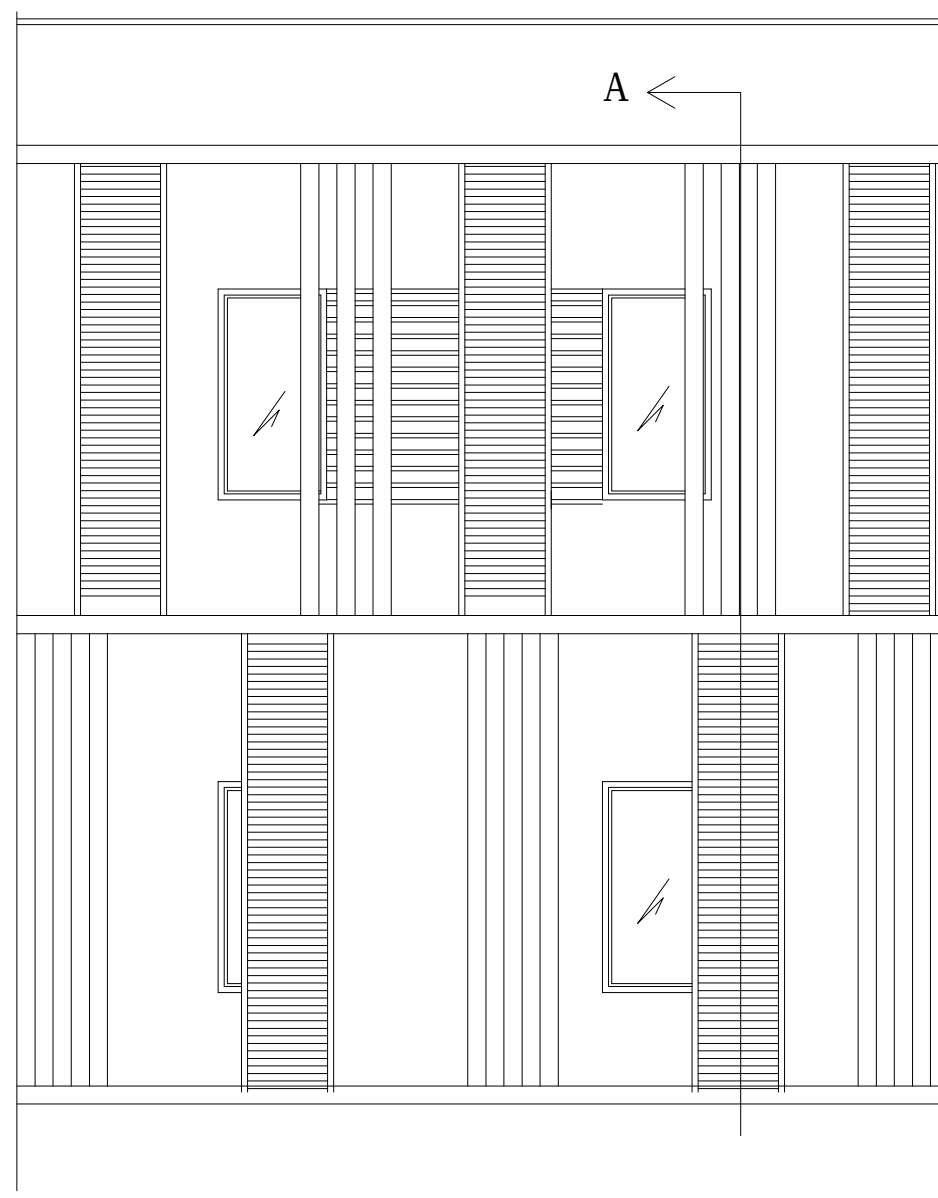


3" M.S FRAME PIPE

2"x3" M.S FRAME PIPE

3/4"x3" M.S LOUVRED PIPE
WELED WITH FRAME

CLIENT.
GOVERNMENT COLLEGE UNIVERSITY
FAISALABAD

PROJECT.
ESTABLISHMENT OF CHINIOT CAMPUS
GOVERNMENT COLLEGE UNIVERSITY
FAISALABAD

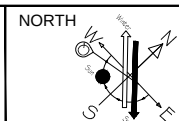

DWG. TITLE
ACADEMIC BLOCK
FRONT BALCONY DETAIL

DWG. NO
A - 16

CONSULTANTS
DEVELOPMENT CONSULTANCY SERVICES (Pvt.) Ltd.
Office 27, 2nd Floor, Executive complex, G-8 Markaz,
Islamabad
Phone: 051-8736305