
 


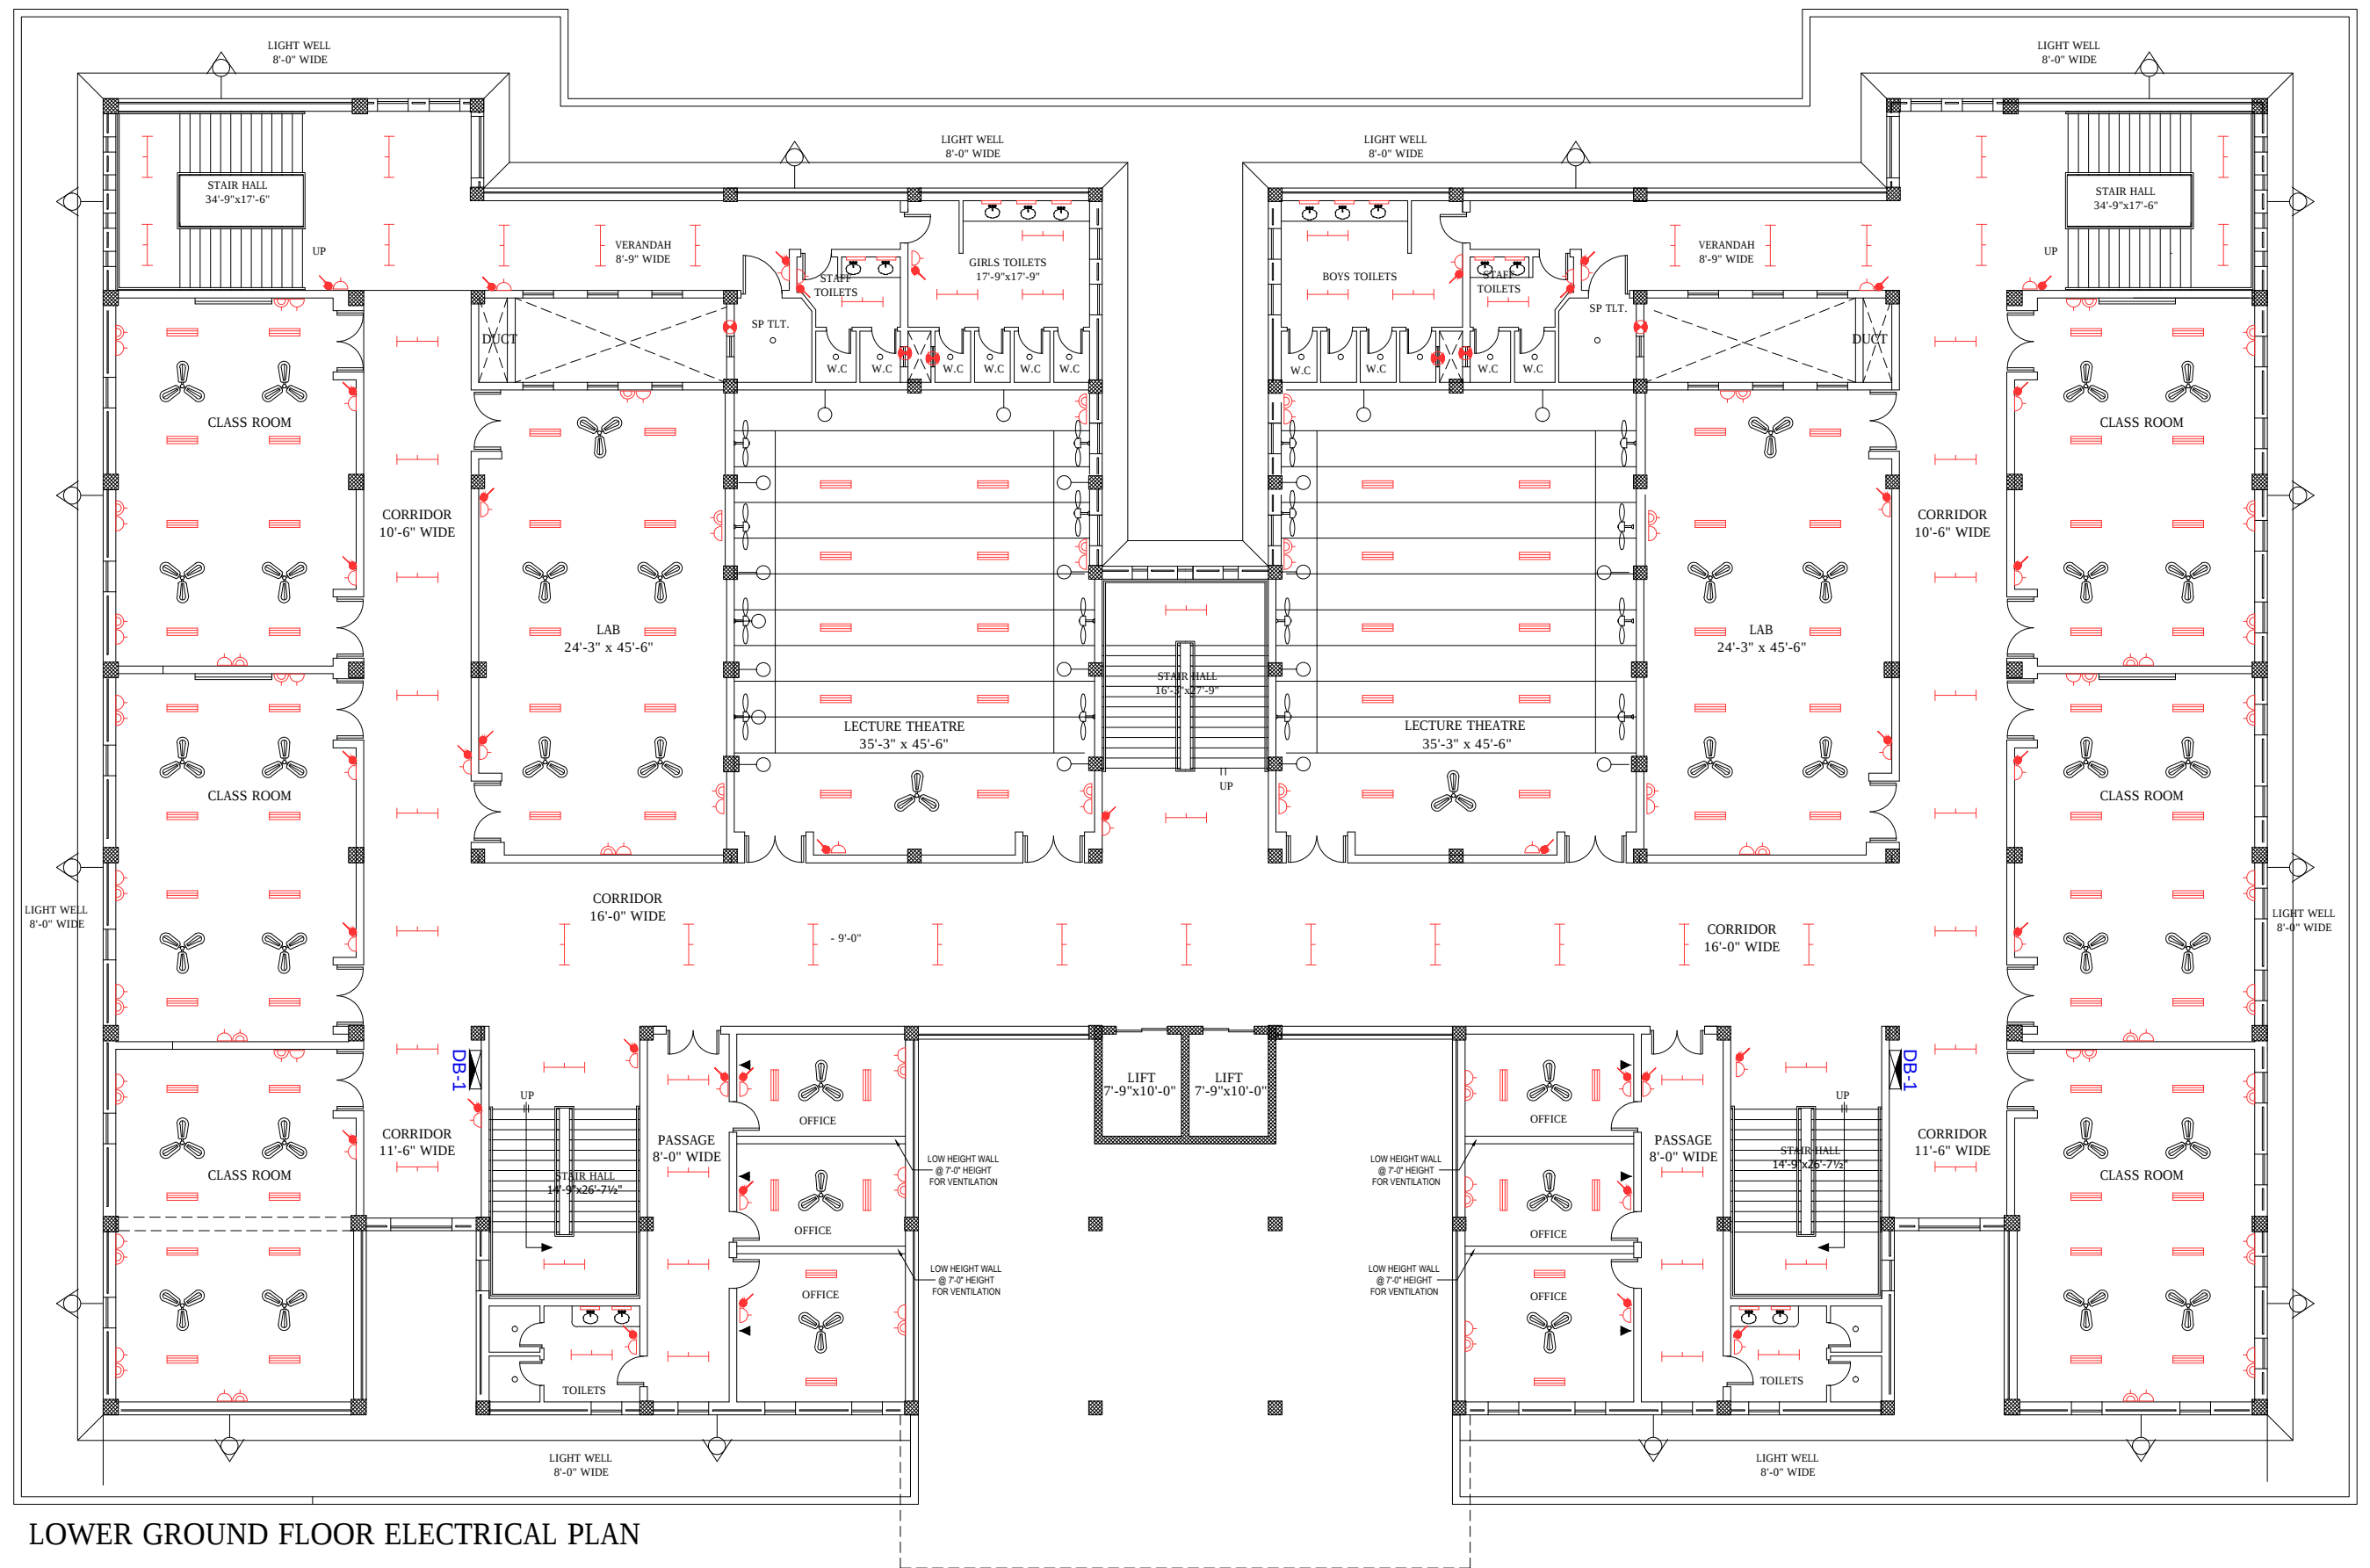

CLIENT.
GOVERNMENT COLLEGE UNIVERSITY
FAISALABAD

PROJECT.
ESTABLISHMENT OF CHINIOT CAMPUS
GOVERNMENT COLLEGE UNIVERSITY
FAISALABAD



DWG. TITLE

ACADEMIC BLOCK
LOWER GROUND FLOOR
LIGHTING & POWER PLAN

DESIGN BY
DATE
OCT , 2020

DRAW BY
DWG. NO
E - 02

CONSULTANTS



DEVELOPMENT CONSULTANCY SERVICES (Pvt.) Ltd.
Office 27, 2nd Floor, Executive complex, G-8 Markaz,
Islamabad
Phone: 051-8736305