


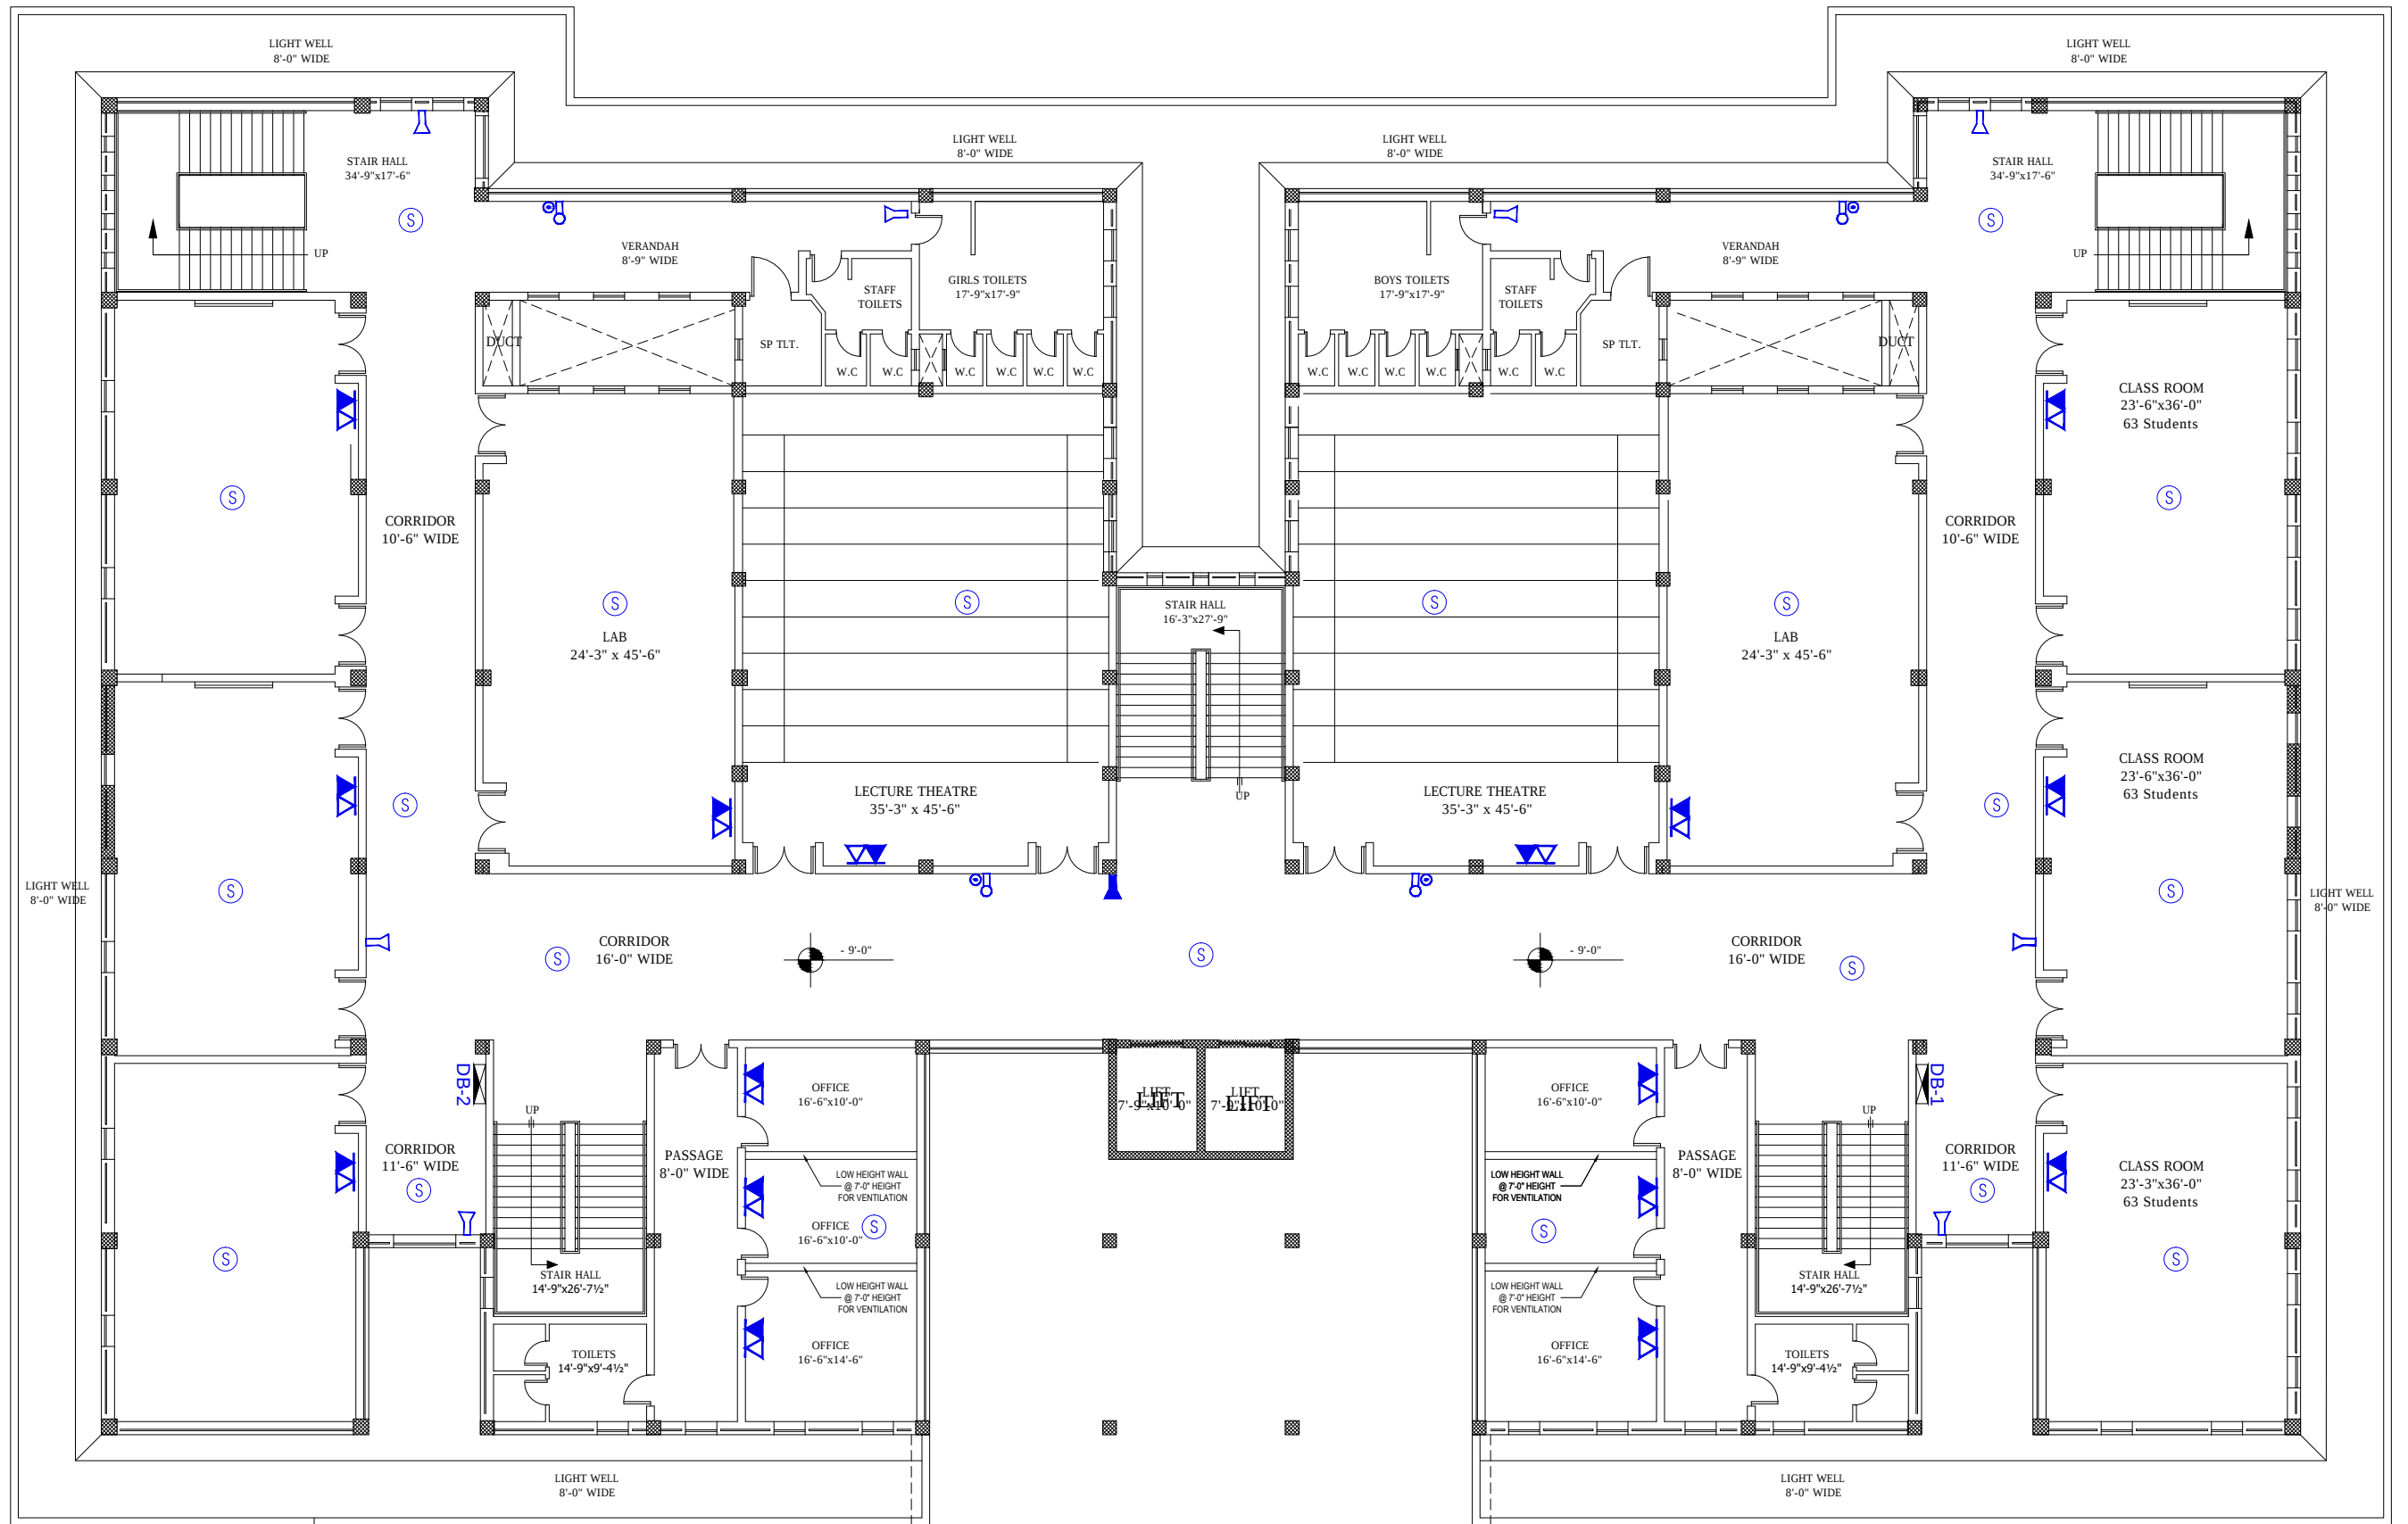

LOWER GROUND FLOOR PLAN

CLIENT. GOVERNMENT COLLEGE UNIVERSITY FAISALABAD	PROJECT. ESTABLISHMENT OF CHINIOT CAMPUS GOVERNMENT COLLEGE UNIVERSITY FAISALABAD	NORTH 	DWG. TITLE ACADEMIC BLOCK LOWER GROUND FLOOR TELEPHONE, CCTV & FIRE ALARM SYSTEM PLAN	DESIGN BY DATE OCT , 2020	DRAW BY DWG. NO E - 07	CONSULTANTS  DEVELOPMENT CONSULTANCY SERVICES (Pvt.) Ltd. Office 27, 2nd Floor, Executive complex, G-8 Markaz, Islamabad Phone: 051-8736305
---	---	---	---	--	-------------------------------------	--