


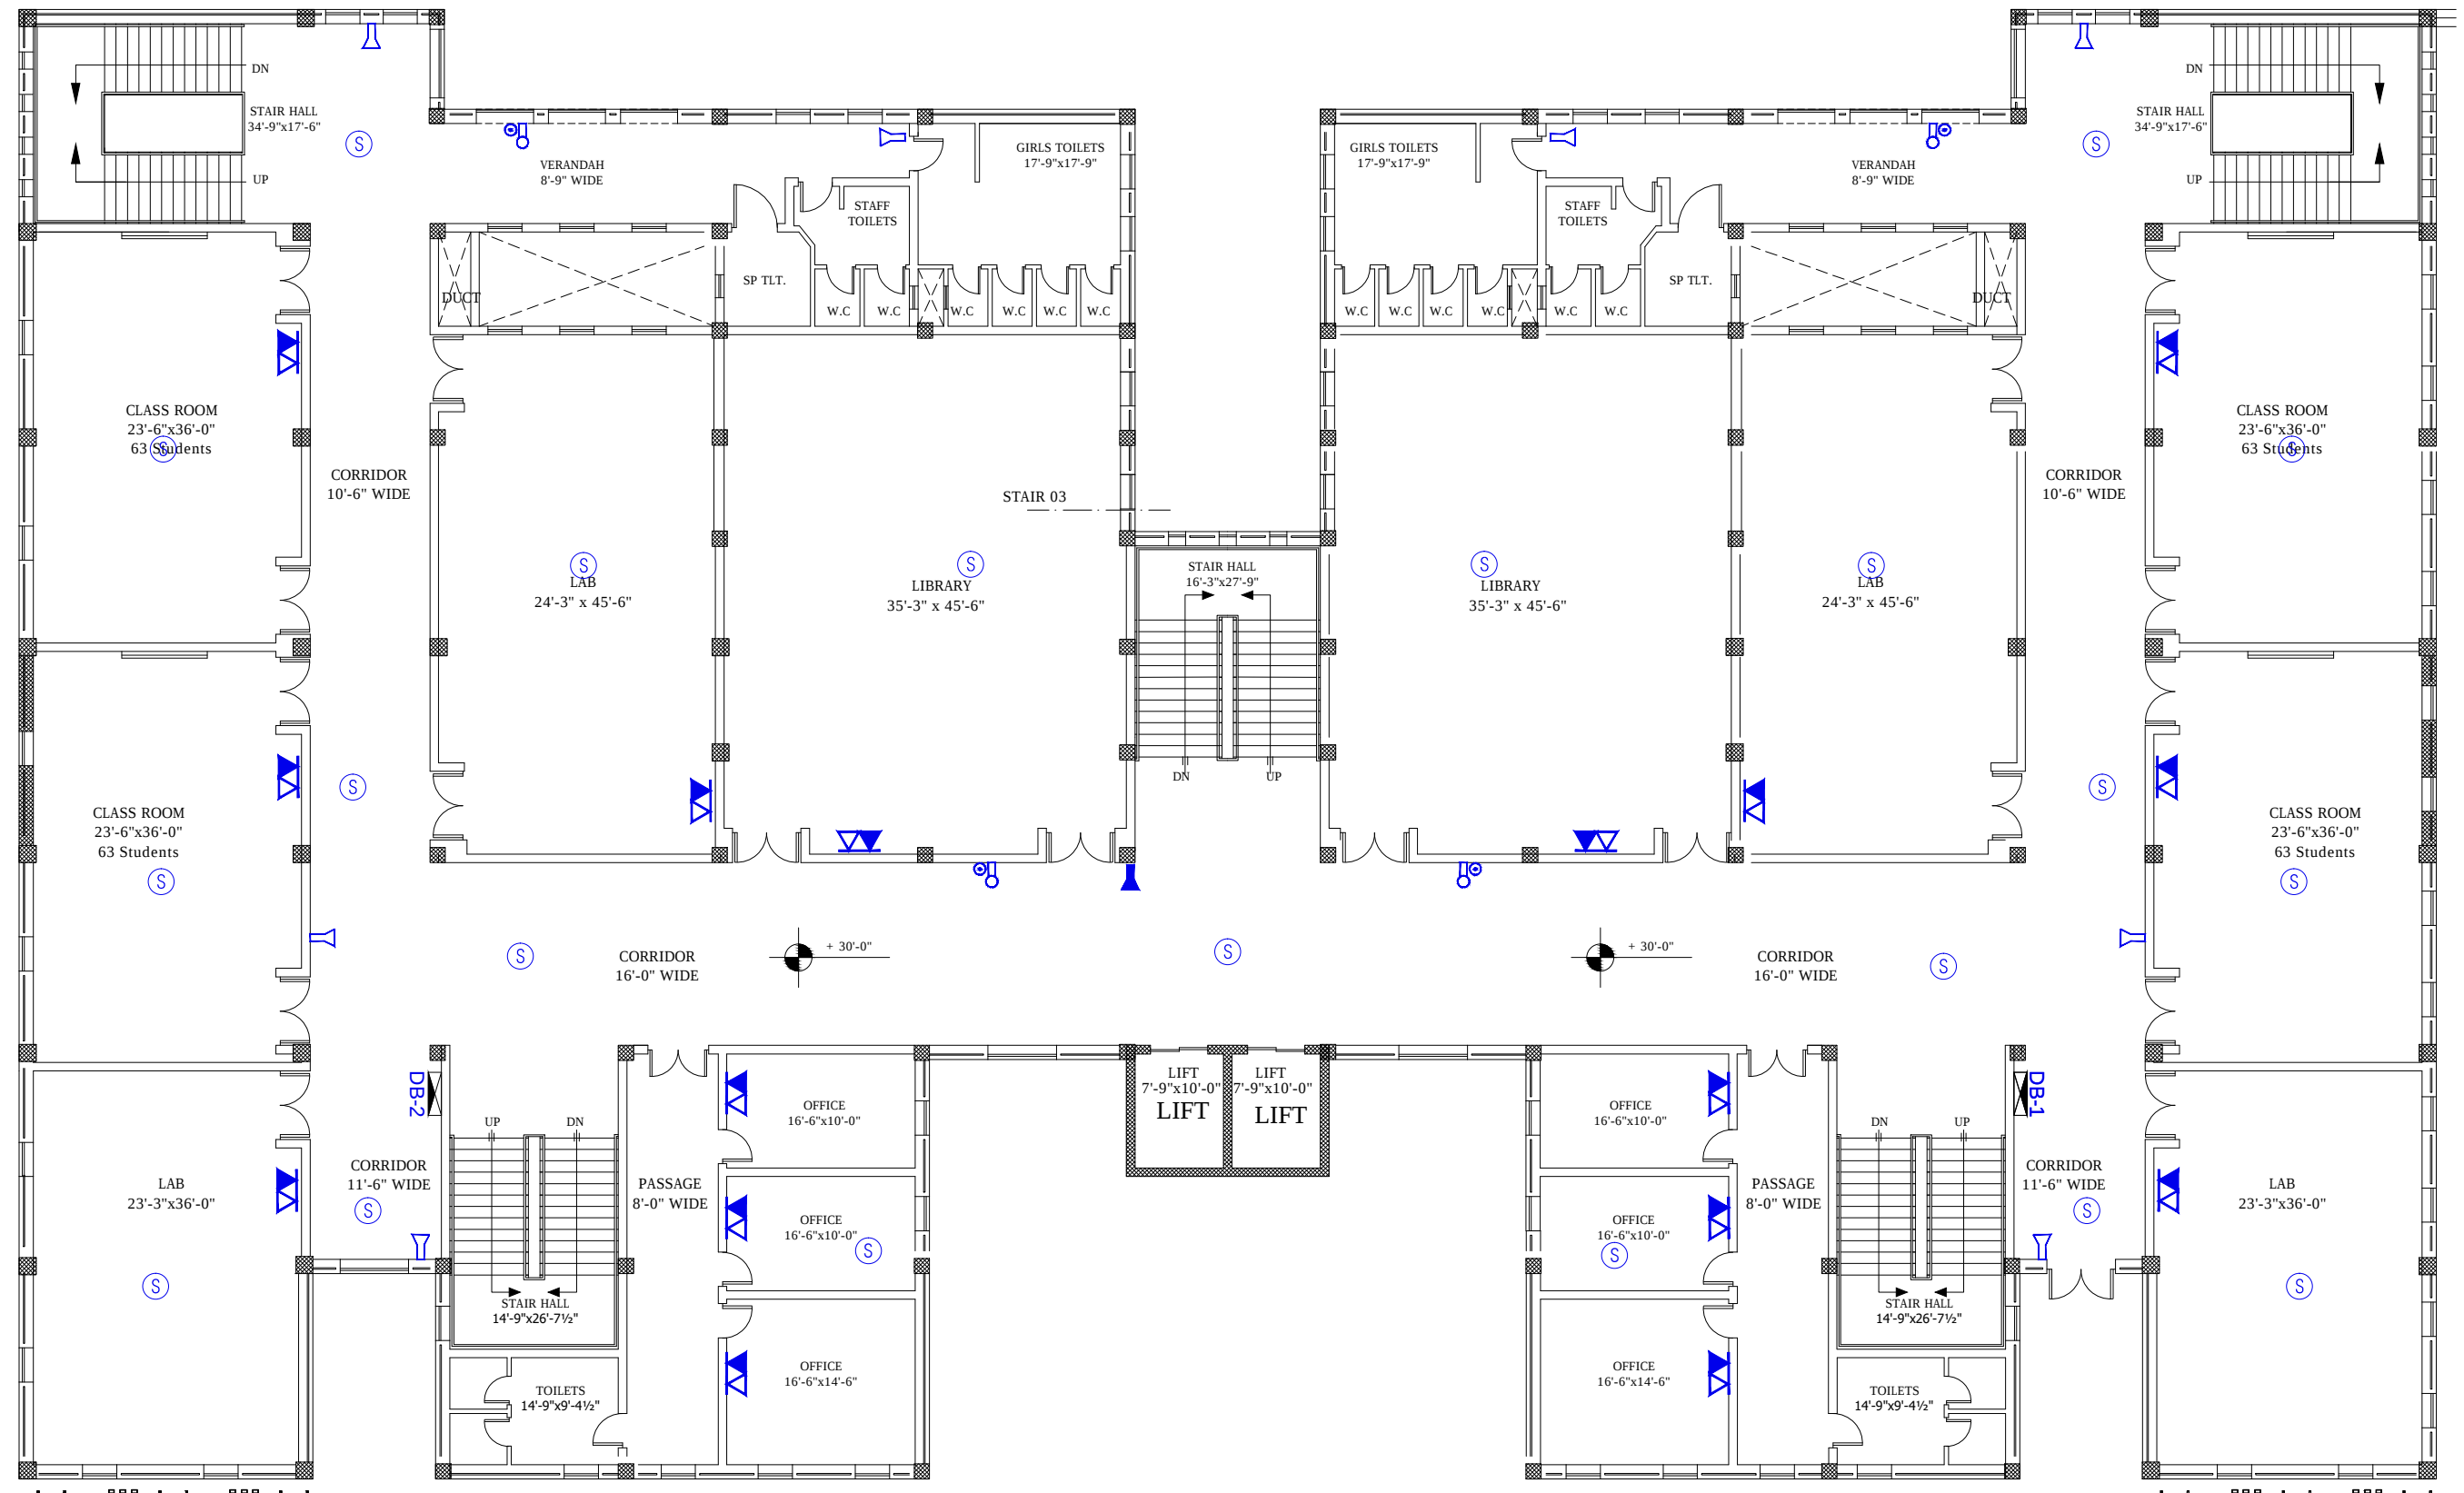

SECOND FLOOR PLAN

CLIENT. GOVERNMENT COLLEGE UNIVERSITY FAISALABAD	PROJECT. ESTABLISHMENT OF CHINIOT CAMPUS GOVERNMENT COLLEGE UNIVERSITY FAISALABAD	NORTH 	DWG. TITLE ACADEMIC BLOCK SECOND FLOOR TELEPHONE , CCTV & FIRE ALARM SYSTEM	DESIGN BY AFTAB KHAN DATE OCT , 2020	DRAW BY DWG. NO E - 10	CONSULTANTS  DEVELOPMENT CONSULTANCY SERVICES (Pvt.) Ltd. Office 27, 2nd Floor, Executive complex,G-8 Markaz, Islamabad Phone: 051-8736305
---	---	------------------	---	---	--	---