


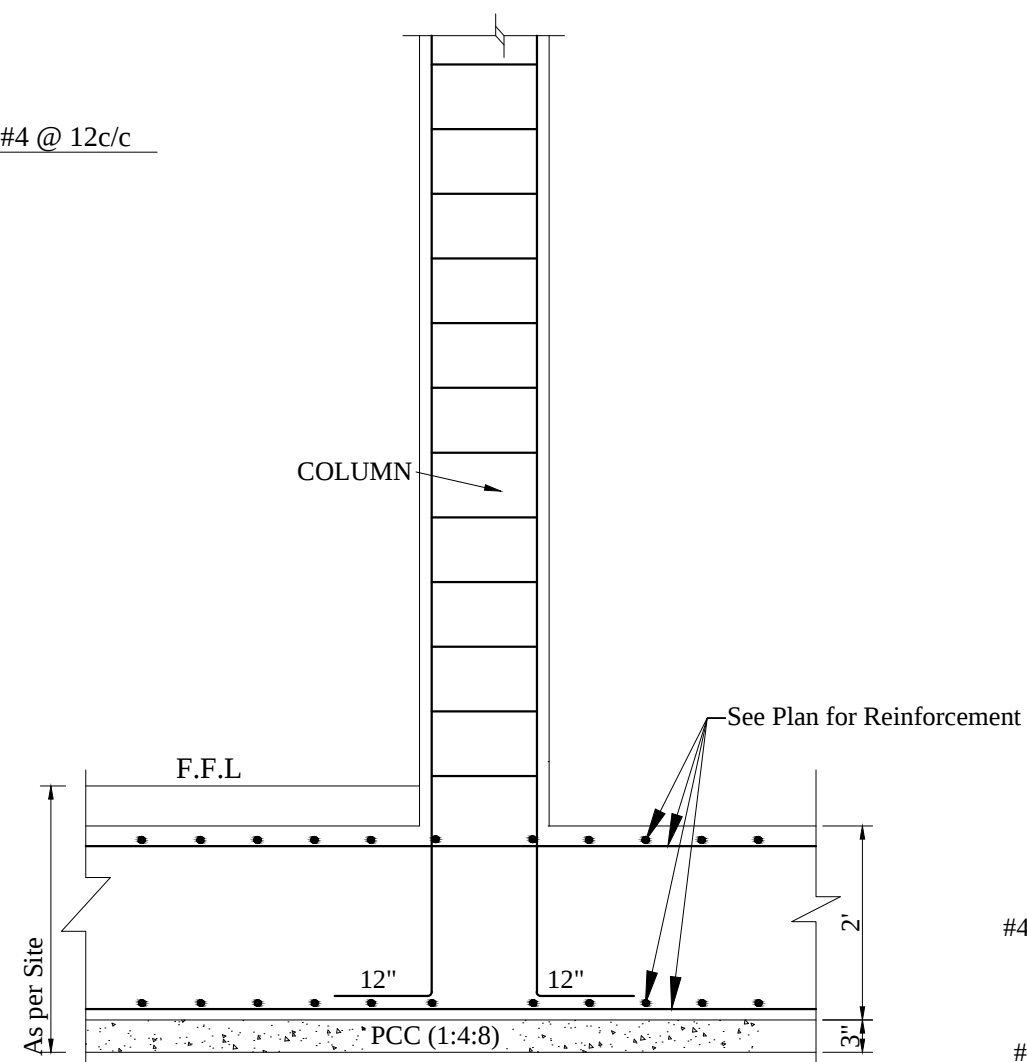
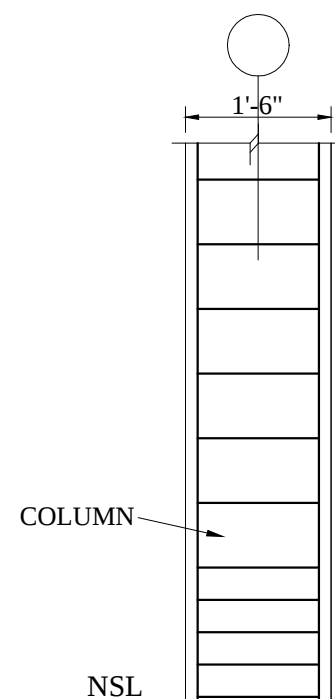
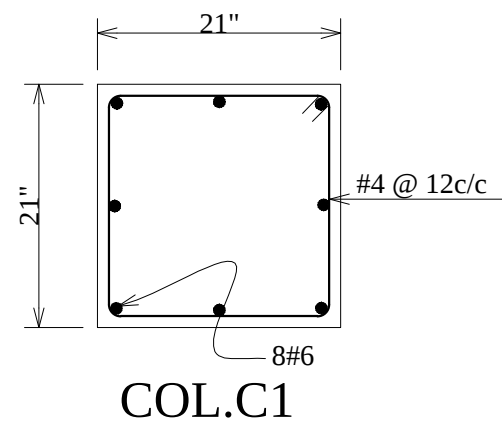


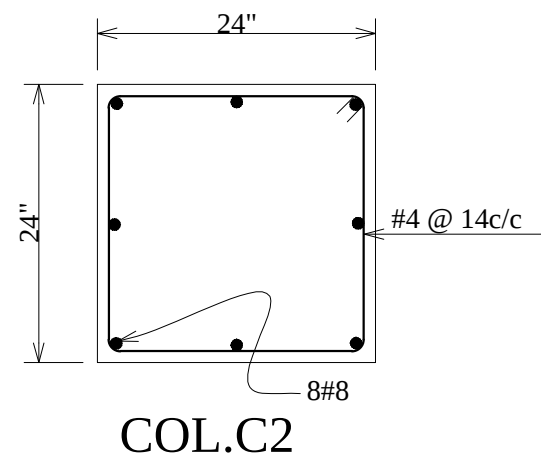

SECTION -Y

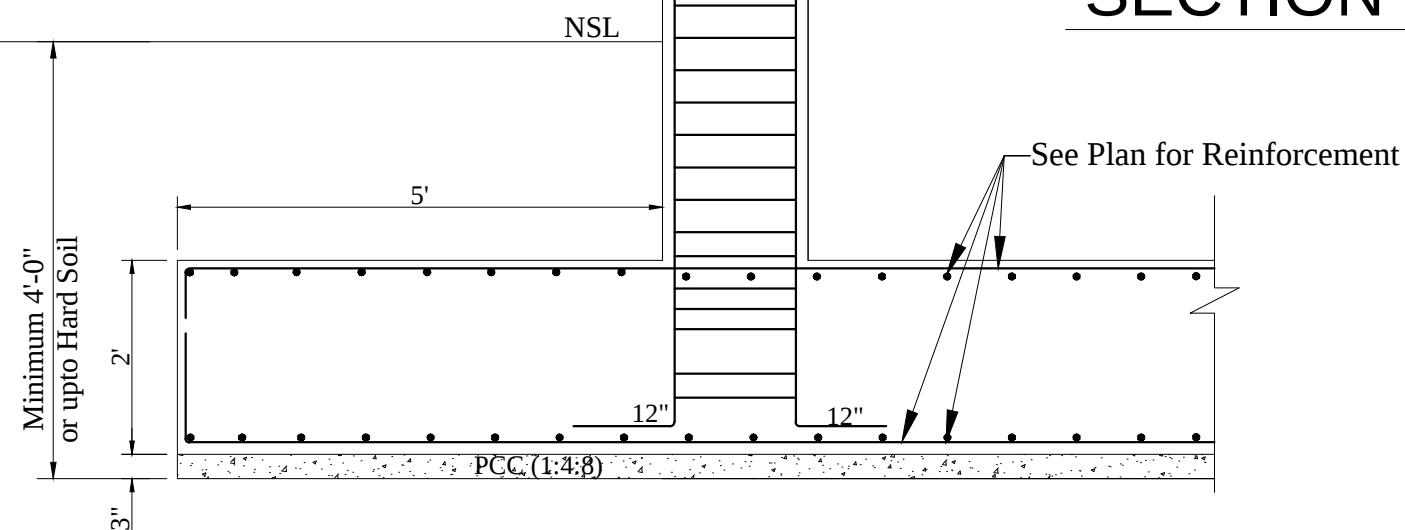


SECTION -X

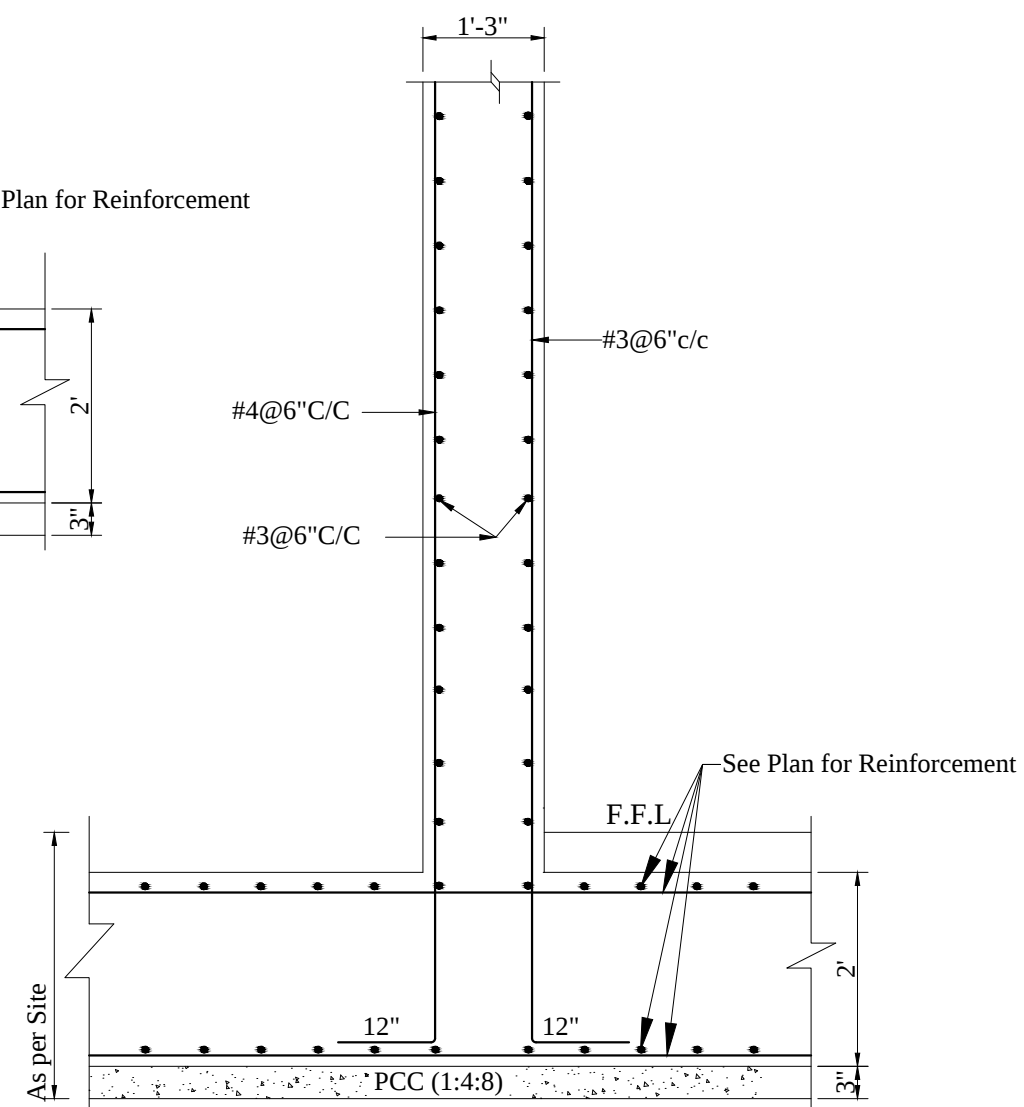

RCC Wall Section-A

CLIENT.
GOVERNMENT COLLEGE UNIVERSITY
FAISALABAD

PROJECT.
ESTABLISHMENT OF CHINIOT CAMPUS
GOVERNMENT COLLEGE UNIVERSITY
FAISALABAD

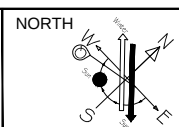

DWG. TITLE
ACADEMIC BLOCK
RAFT& RCC WALL SECTION DETAILS

DESIGN BY
AFTAB KHAN
DATE
OCT , 2020

DRAW BY
DWG. NO
S - 04

CONSULTANTS
 **DEVELOPMENT CONSULTANCY SERVICES (Pvt.) Ltd.**
Office 27, 2nd Floor, Executive complex,G-8 Markaz,
Islamabad
Phone: 051-8736305